

**SCOPE OF WORK**



1. INSTALLATION OF NEW AUXILIARY DRAINS, DRUM DRIPS AND ASSOCIATED PIPING FOR THE EXISTING SPRINKLER INSTALLED THROUGHOUT THE DERRY TRANSFER STATION IN DERRY, NH.

**GENERAL NOTES**

1. ALL GENERAL NOTES & DETAILS ARE TO BE CONSIDERED APPLICABLE TO ALL SPRINKLER DRAWINGS FOR THIS PROJECT. REFERENCE PROJECT NARRATIVE AND SPECIFICATION FOR FURTHER DETAILS.
2. THE DRAWINGS ARE DIAGRAMMATIC IN NATURE AND EXACT LOCATIONS AND ARRANGEMENTS OF EQUIPMENT SHALL BE DETERMINED IN FIELD WITH DUE CONSIDERATION OF STRUCTURAL, ELECTRICAL AND ARCHITECTURAL SYSTEMS.
3. CONTRACTOR IS RESPONSIBLE FOR OBTAINING ALL PERMITS AND APPROVALS.


**INSTALLATION NOTES**

1. INSTALL EQUIPMENT IN ACCORDANCE WITH THE MANUFACTURER'S RECOMMENDATIONS AND GOOD PRACTICE NORMAL TO THE TRADE. INSTALLATION SHALL INCLUDE PROVISIONS FOR ACCESS TO NORMAL MAINTENANCE ITEMS. PROVIDE ADEQUATE STRUCTURAL SUPPORTS AND SECURE MOUNTING METHODS WITH PROVISIONS FOR VIBRATION ISOLATION AND EXPANSION WHERE REQUIRED.
2. ALL PIPE LOCATIONS ARE TO BE FIELD MEASURED PRIOR TO FABRICATION AND INSTALLATION BY SPRINKLER CONTRACTOR. ALL CHANGES TO BE INCORPORATED ON AS-BUILTS.
3. ALL SYSTEMS TO BE FLUSHED AND HYDROSTATICALLY TESTED IN ACCORDANCE TO NFPA 25 BEFORE BEING PLACED IN SERVICE.
4. HANGERS ARE TO BE U.L. LISTED AND F.M. APPROVED.
5. PROVIDE CLAMPS, OFFSETS, EXPANSION JOINTS, ANCHORS & GUIDES AS NECESSARY TO PREVENT UNDUE STRAIN ON PIPING.
6. INSPECTION/TEST DRAIN ASSEMBLES SHALL BE PIPED TO GRADE. COORDINATE LOCATIONS WITH OWNERS REPRESENTATIVE. DRAIN PIPING SHALL BE BLACK STEEL.
7. PIPING TO BE SUPPORTED PER NFPA 13.
8. NEW PIPING TO BE LISTED BLACK STEEL.
- 8.1. ALL PIPING TO BE SCHEDULE 40 BLACK STEEL WITH THREADED FITTINGS.

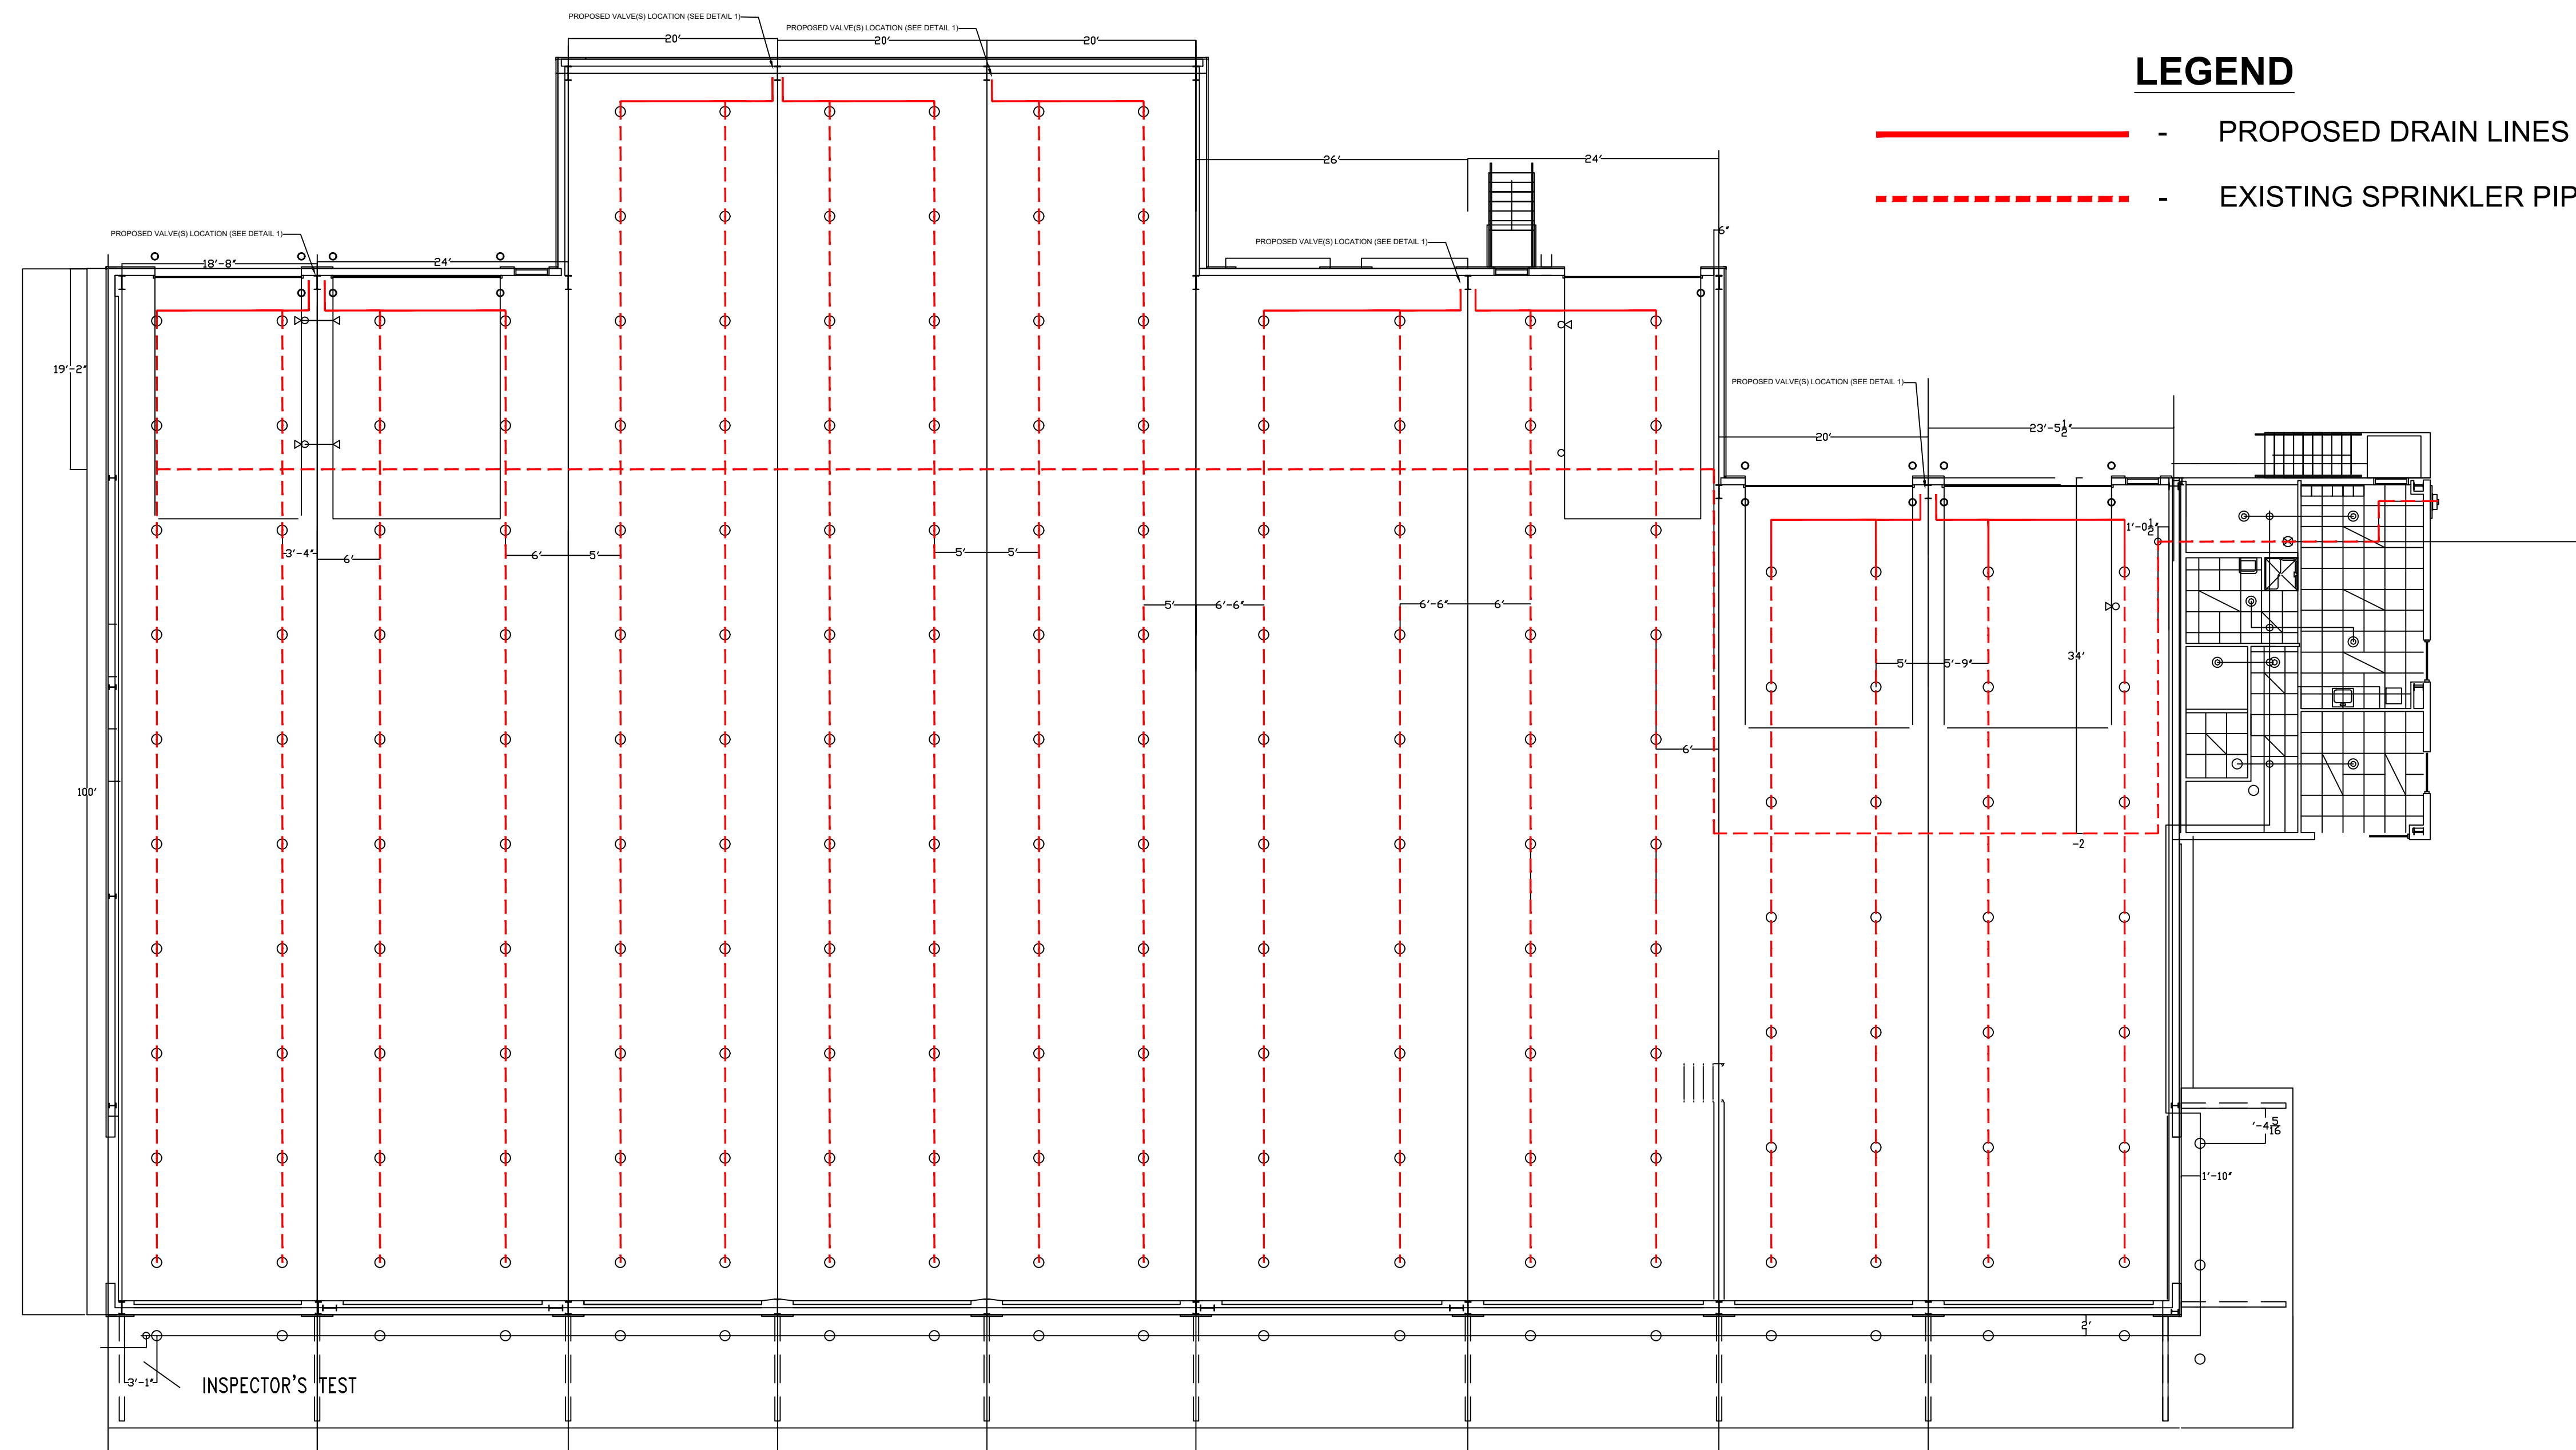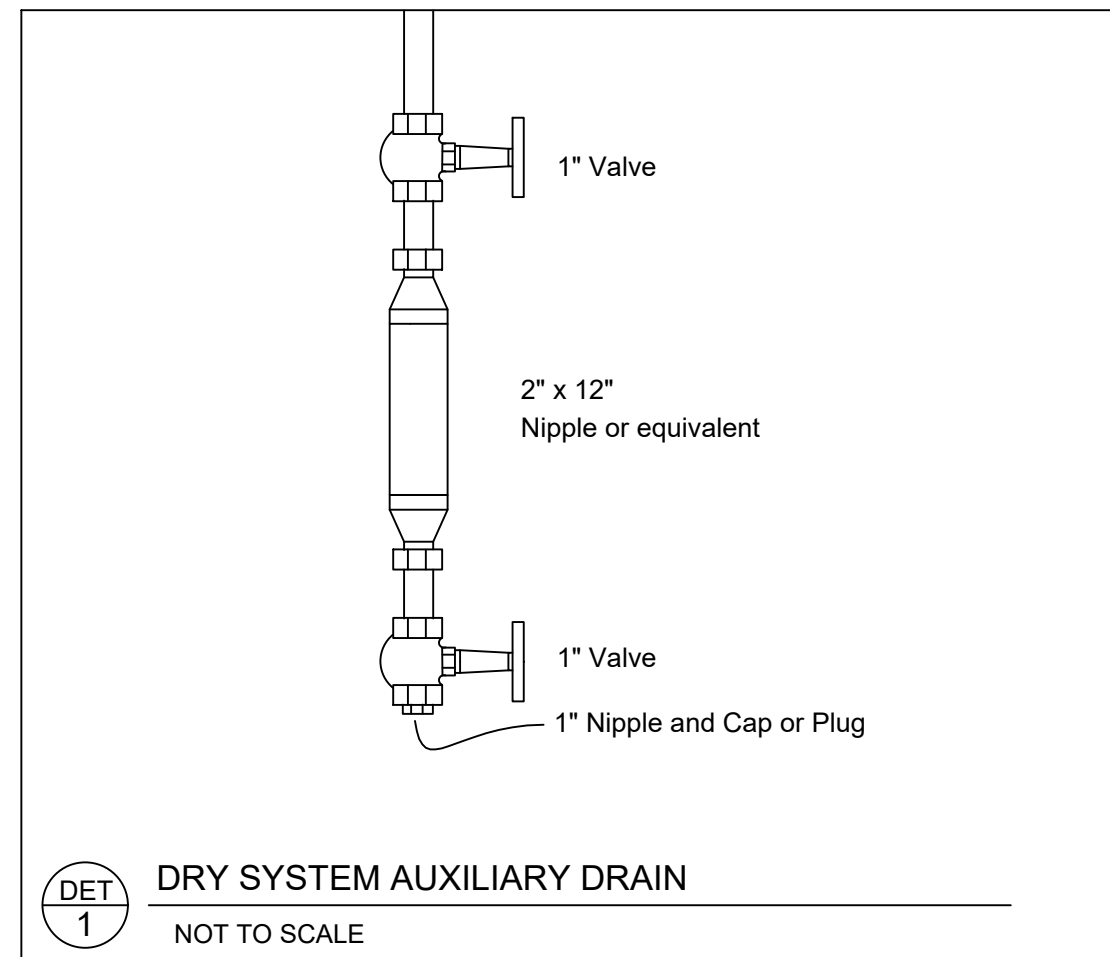

**LEGEND**

- - PROPOSED DRAIN LINES
- - - - - - EXISTING SPRINKLER PIPE

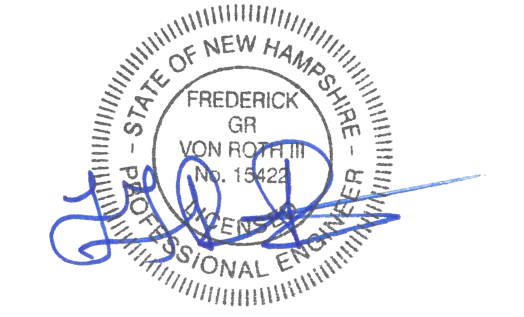

**ISSUED FOR:**  
**BID**

**REVISIONS**

NO.	DESCRIPTION	DATE

**Derry Transfer Station**  
 Derry, NH

**FIRE PROTECTION DETAILS**

PROJECT #: 664850  
 DESIGNED BY: GPB  
 DRAWN BY: GPB  
 CHECKED BY: GvR  
 DATE: 11/21/2022

SHEET NO.:  
**FP-001**  
 SHEET 1 OF 1